


GENERAL FLOOR PLAN NOTES


1. ALL FIXTURES, FINISHES, AND COLORS TO BE VERIFIED WITH OWNER, TYP.
2. PRIOR TO CONSTRUCTION, VERIFY ALL CRITICAL DIMENSIONS WITH MANUFACTURER SPECS. FOR PLUMBING FIXTURES, FIREPLACES, OR OTHER EQUIPMENT.

REVISIONS

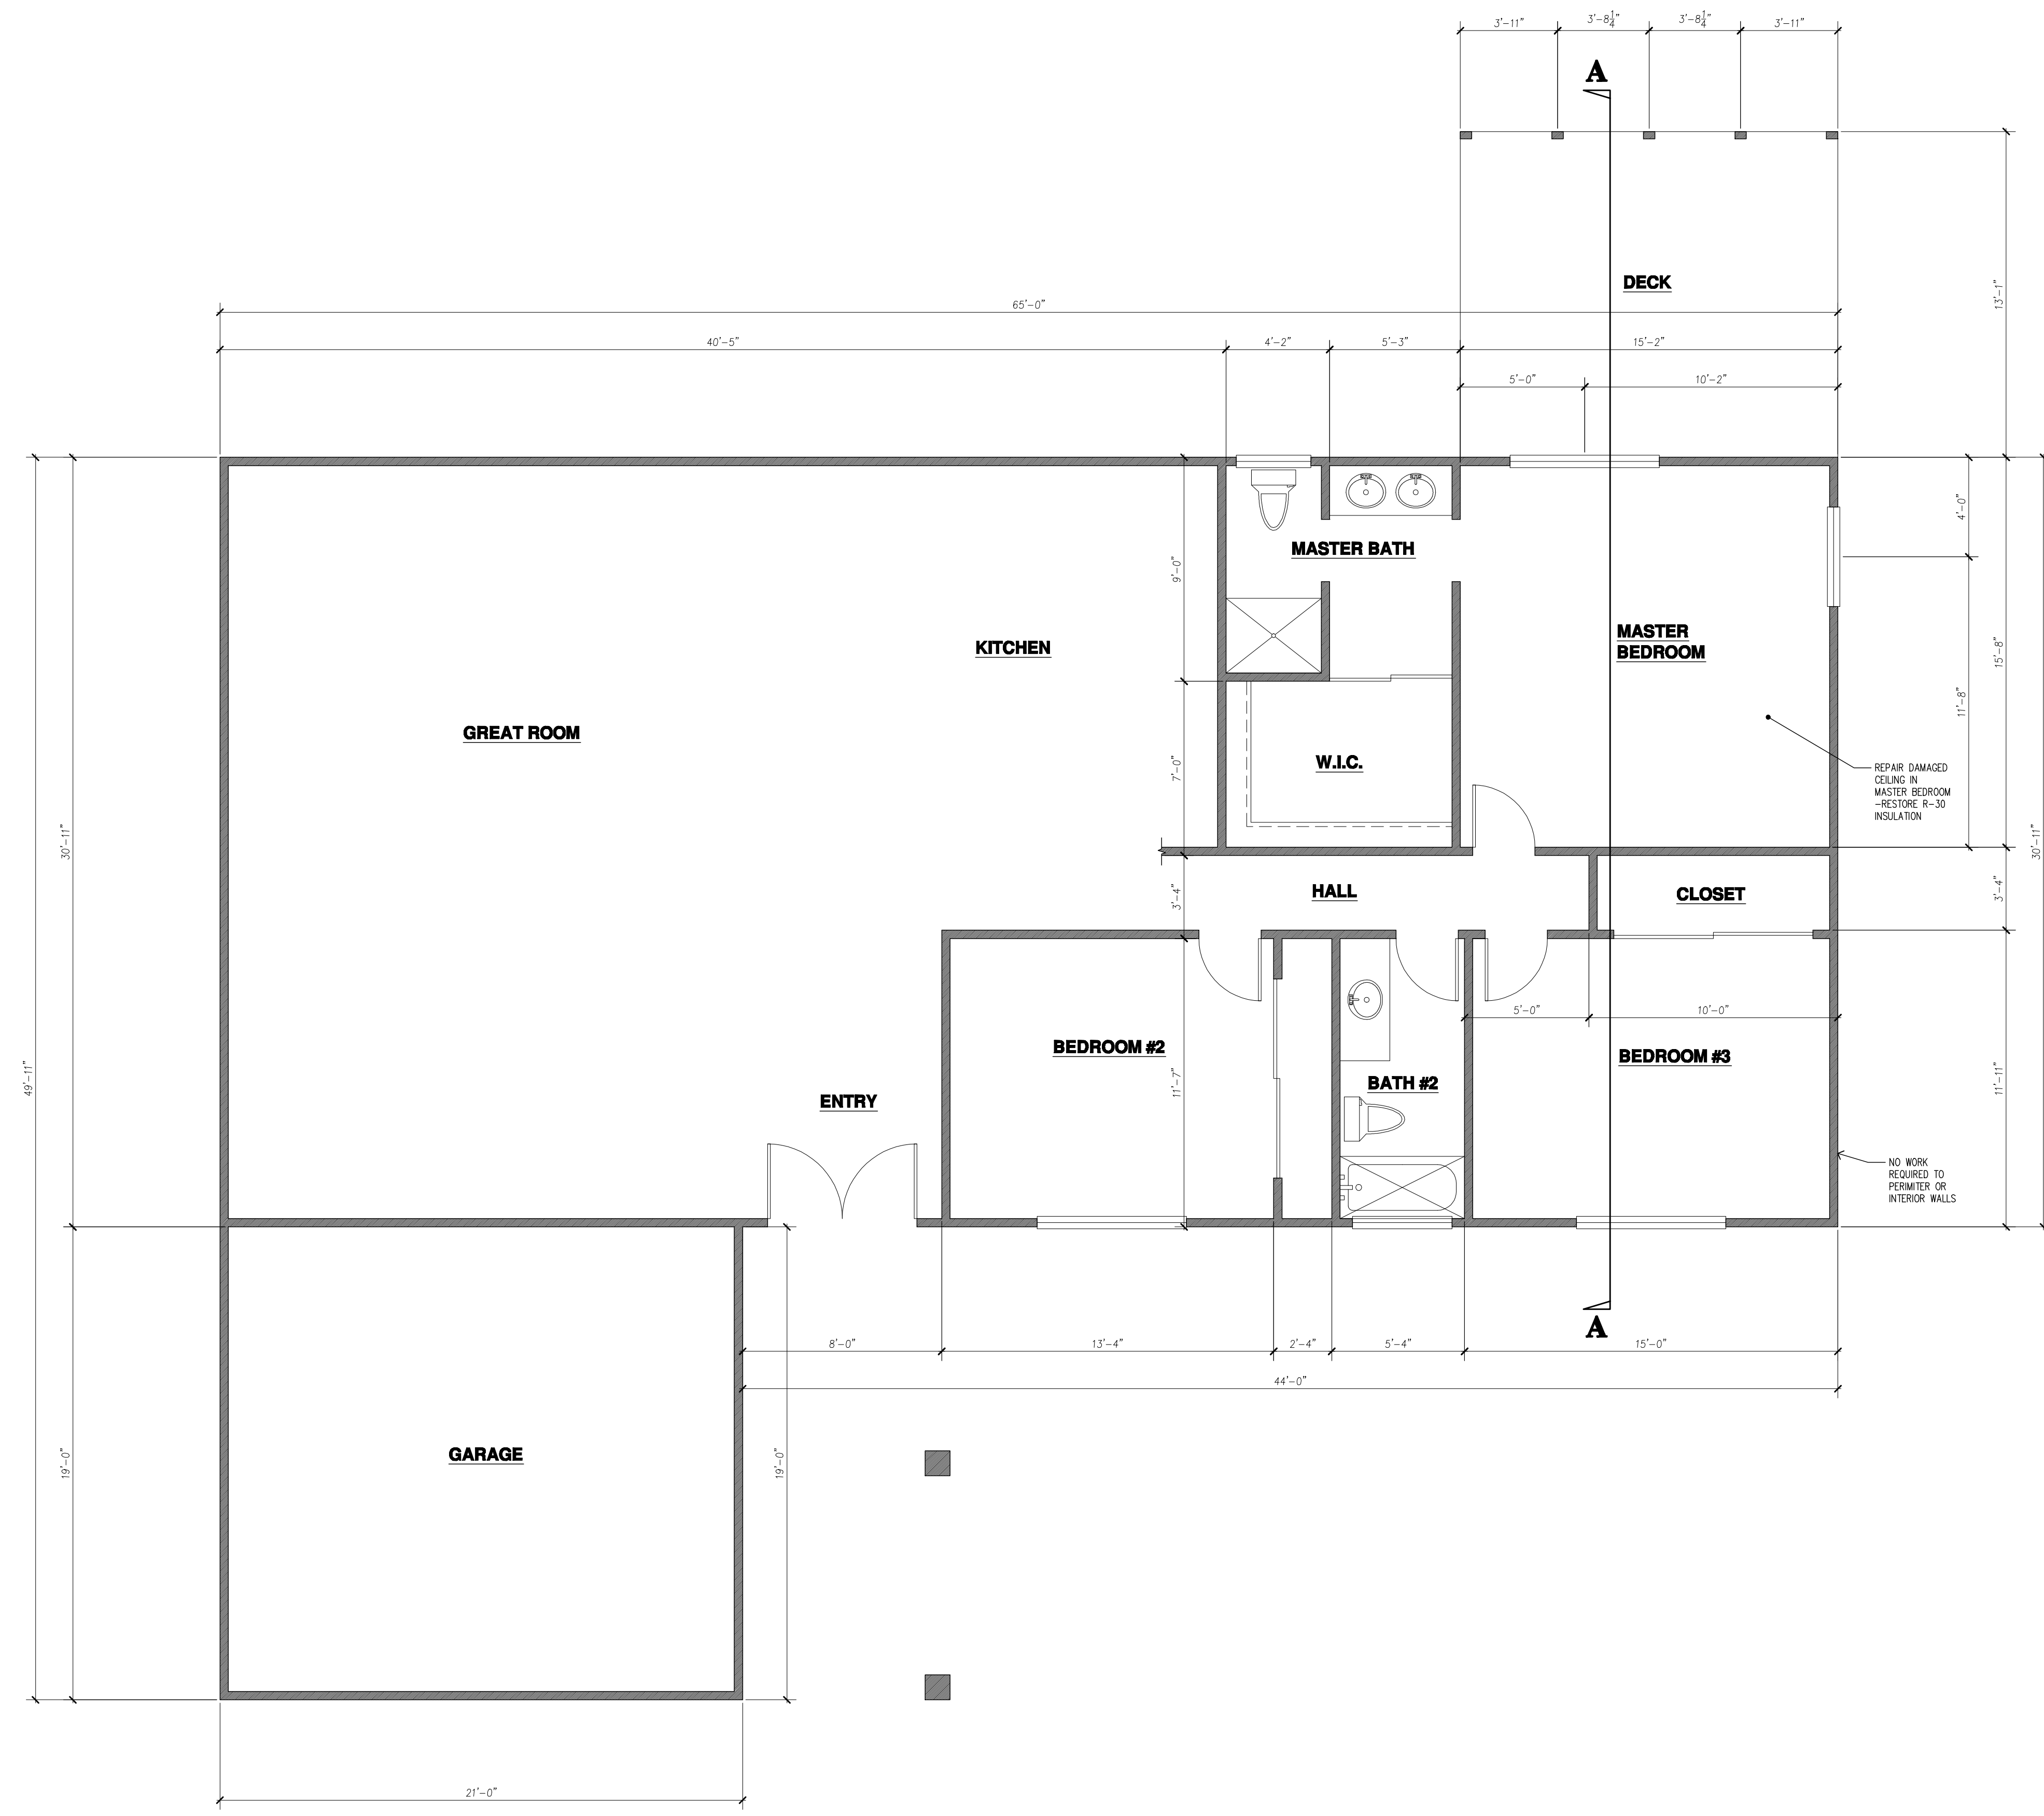


FLOOR PLAN

O'Connor Engineering
 1172 W National Drive, Suite 100
 Sacramento, CA 95834
 Voice: 916-640-0640
 www.oconnor-engineering.com

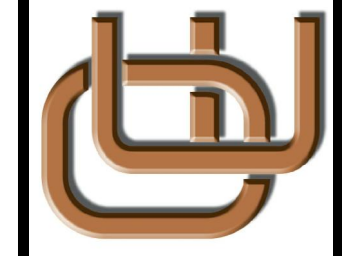

EXAMPLE RESIDENCE REPAIR
 1218 49TH ST.
 SACRAMENTO, CA 95631

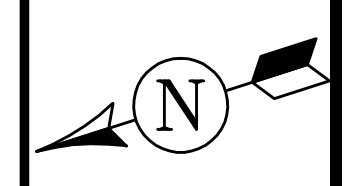

DATE: 12/08
 SCALE: 1/4"=1'-0"
 SHEET

A1